


JOB NO.: 03-91M-14681-0 | DWG DATE: 05-20-2003 | SCALE: 1"=15' | DESIGN BY: EMM | FILE NAME: FIG-2.DWG

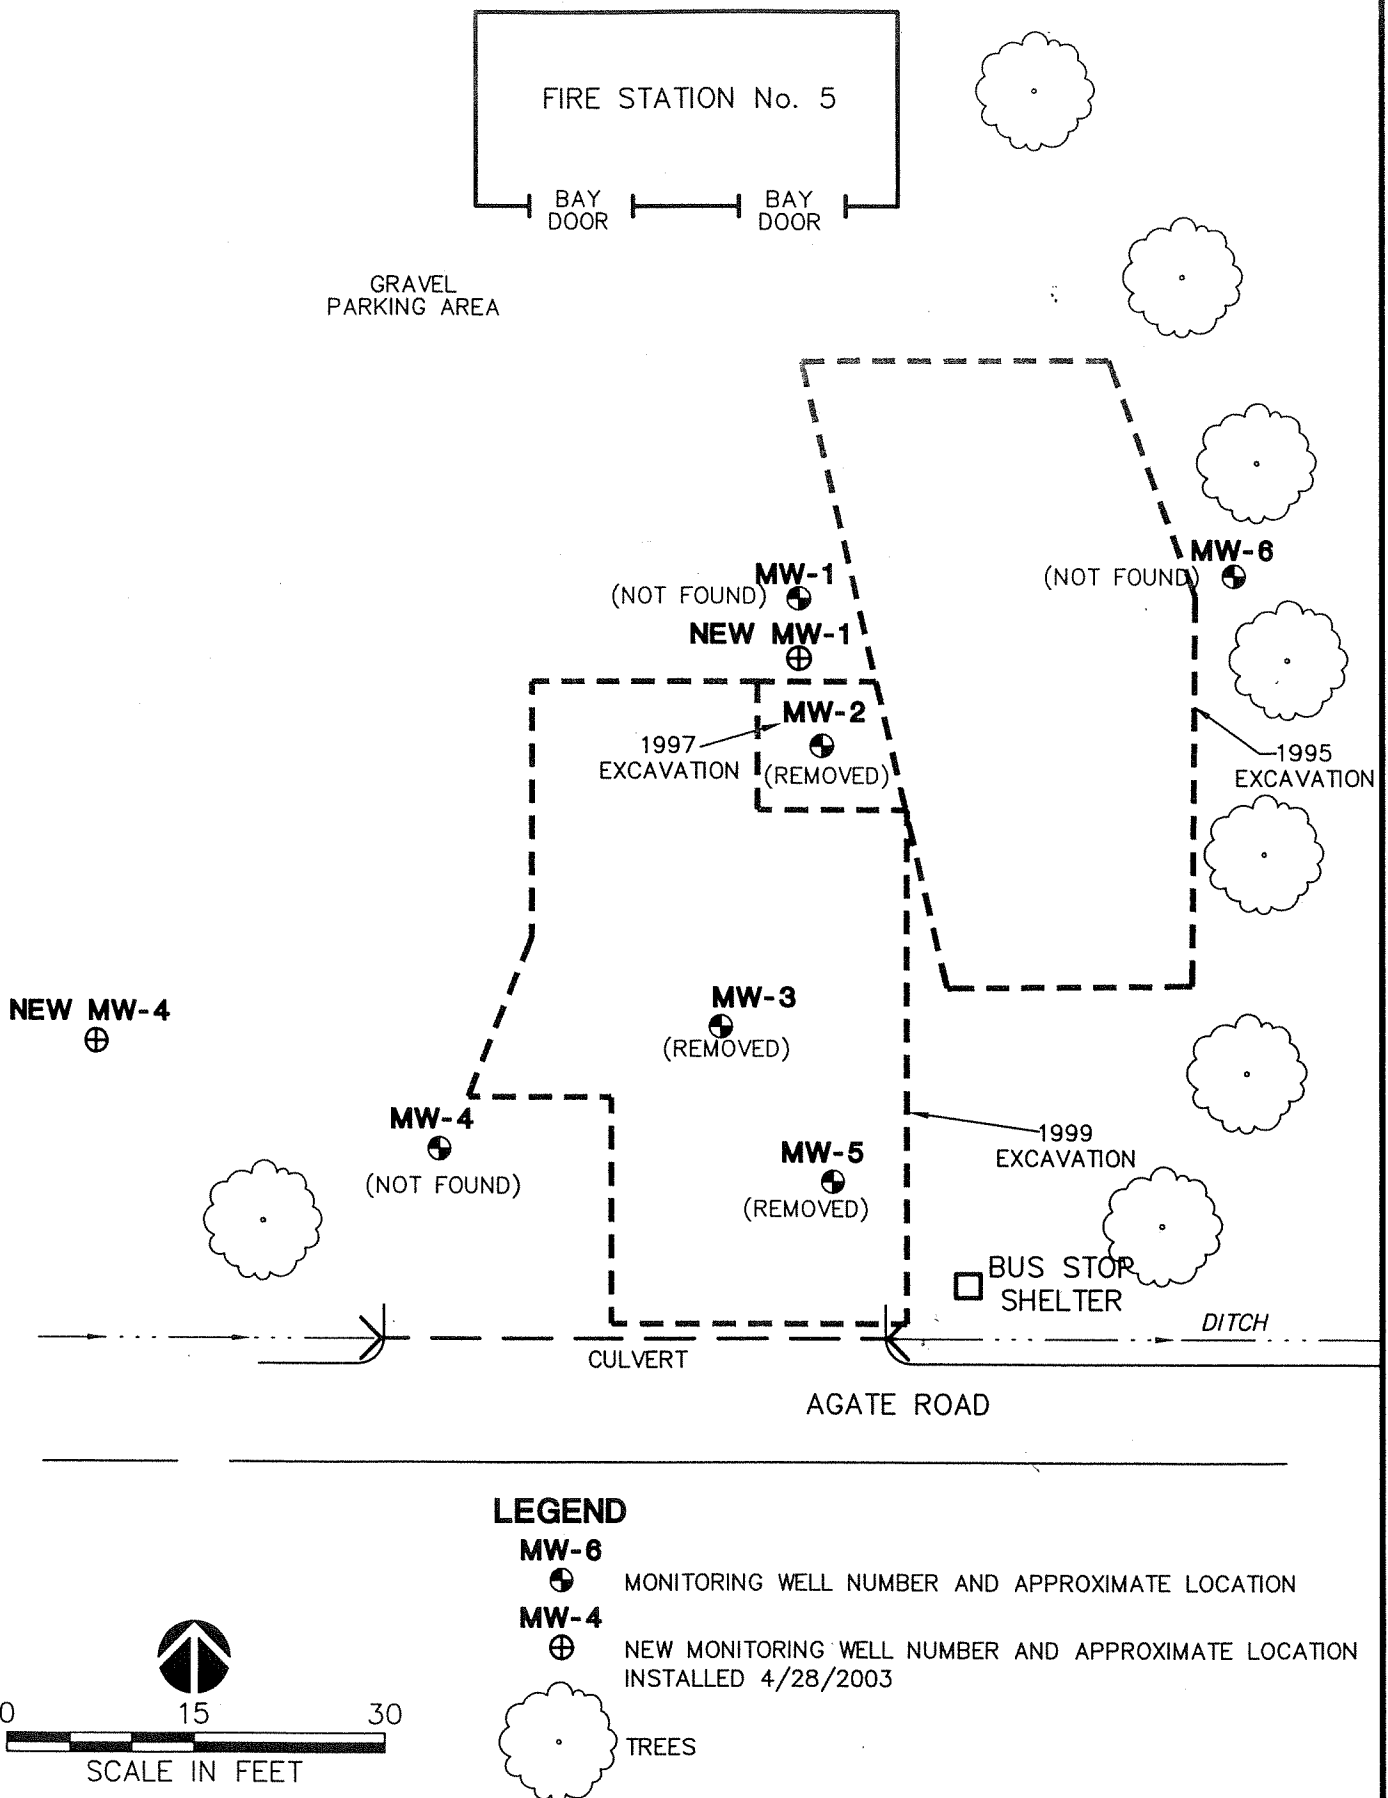

AMEC EARTH AND ENVIRONMENTAL, INC.
11335 N.E. 122nd Way, Suite 100
Kirkland, WA, U.S.A. 98034-6918

SCHEMATIC SITE PLAN

MASON COUNTY FIRE STATION NO. 5

SHELTON, WASHINGTON

FIGURE

2