

REVISIONS:	

Base map supplied by Farallon Consulting.

SITE PLAN
FORMER CHERRY CLEANERS
2510 EAST CHERRY STREET
SEATTLE, WASHINGTON

 




DRAWN BY:	JAB
CHECKED BY:	JP
PROJECT NUMBER:	WS-2510EC
DATE:	9/16/10
SHEET NUMBER:	2

LEGEND	
	TREE
	PINE TREE
	Men & Women Restroom
	GAS METER
	WATER METER
	TEL R TELEPHONE RISER
	TEL V TELEPHONE VAULT
	TRANSMISSION TOWER
	CATCH BASINS
	PAD MOUNTED TRANSFORMER
	POWER POLE or TELEPHONE POLE
	FIRE HYDRANT
	MAN HOLE

LINETYPE STANDARDS	
BARB WIRE FENCE	---
CHAIN LINK FENCE	-.-.-
WOOD FENCE	
WATER LINE	---
STORM SEWER LINE	---
SANITARY SEWER LINE	---
NATURAL GAS LINE	---
UNDERGROUND ELECTRICAL LINE	---
OVERHEAD ELECTRICAL LINE	---
ABOVE GROUND ELEC. LINE	---
COMMUNICATIONS LINE	---
TELEPHONE LINE	---
UNDERGROUND TELEPHONE	---
FIBER OPTICS LINE	---
FIRE WATER LINE	---
TRAFFIC SIGNAL LINE	---
EASEMENT LINE	---
SWALE LINE	---
EDGE OF WATER LINE	---
BUILDING SETBACK LINE	---
RIGHT-OF-WAY LINE	---
PROPERTY LINE	---

EXISTING	
	MONITORING WELL
	DEEP MONITORING WELL
	SOIL VAPOR EXTRACTION WELL
	RECONNAISSANCE GROUND WATER SAMPLE
	INJECTION WELL
	SOIL BORING
	VAPOR MONITORING WELL
	PLANNED MONITORING WELL LOCATION

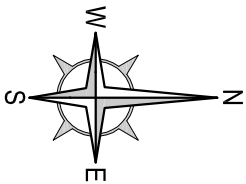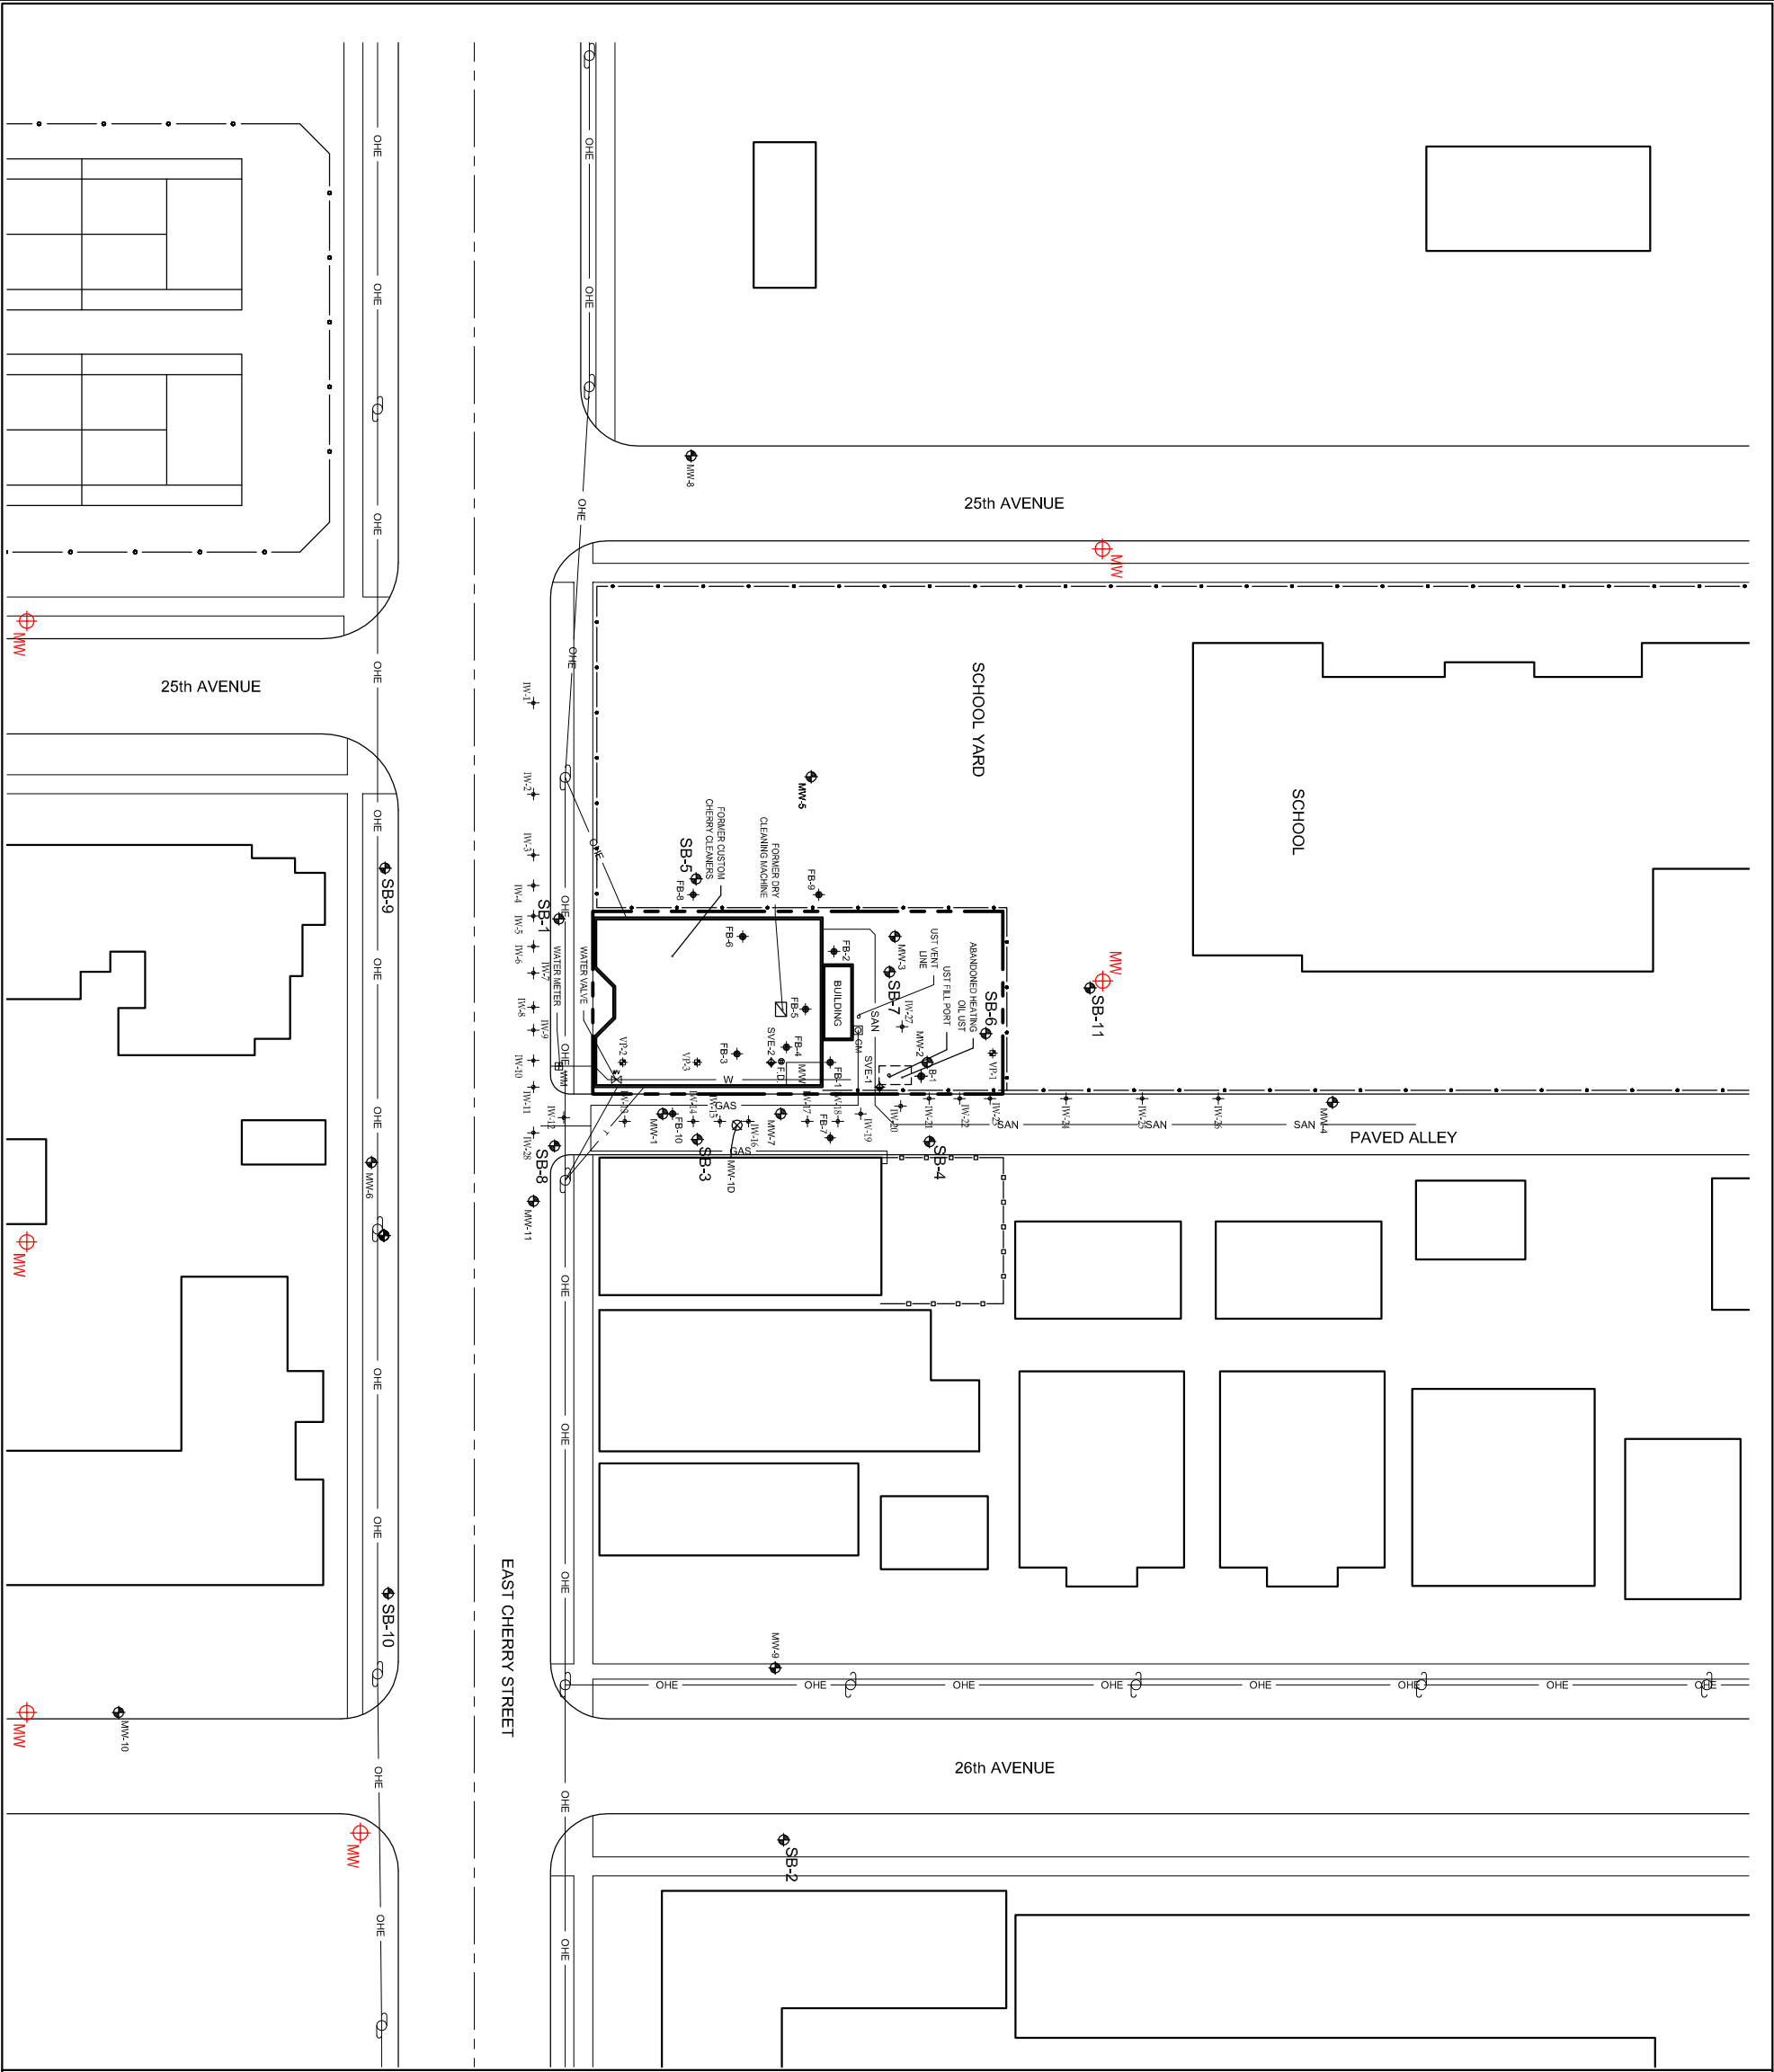

GRAPHIC SCALE: 1" = 20'